


**Project Name**

Construction of Three  
Class Rooms at Resa  
Primary School in Bahrka

**Project Place**

Erbil Governorate

**Legend**

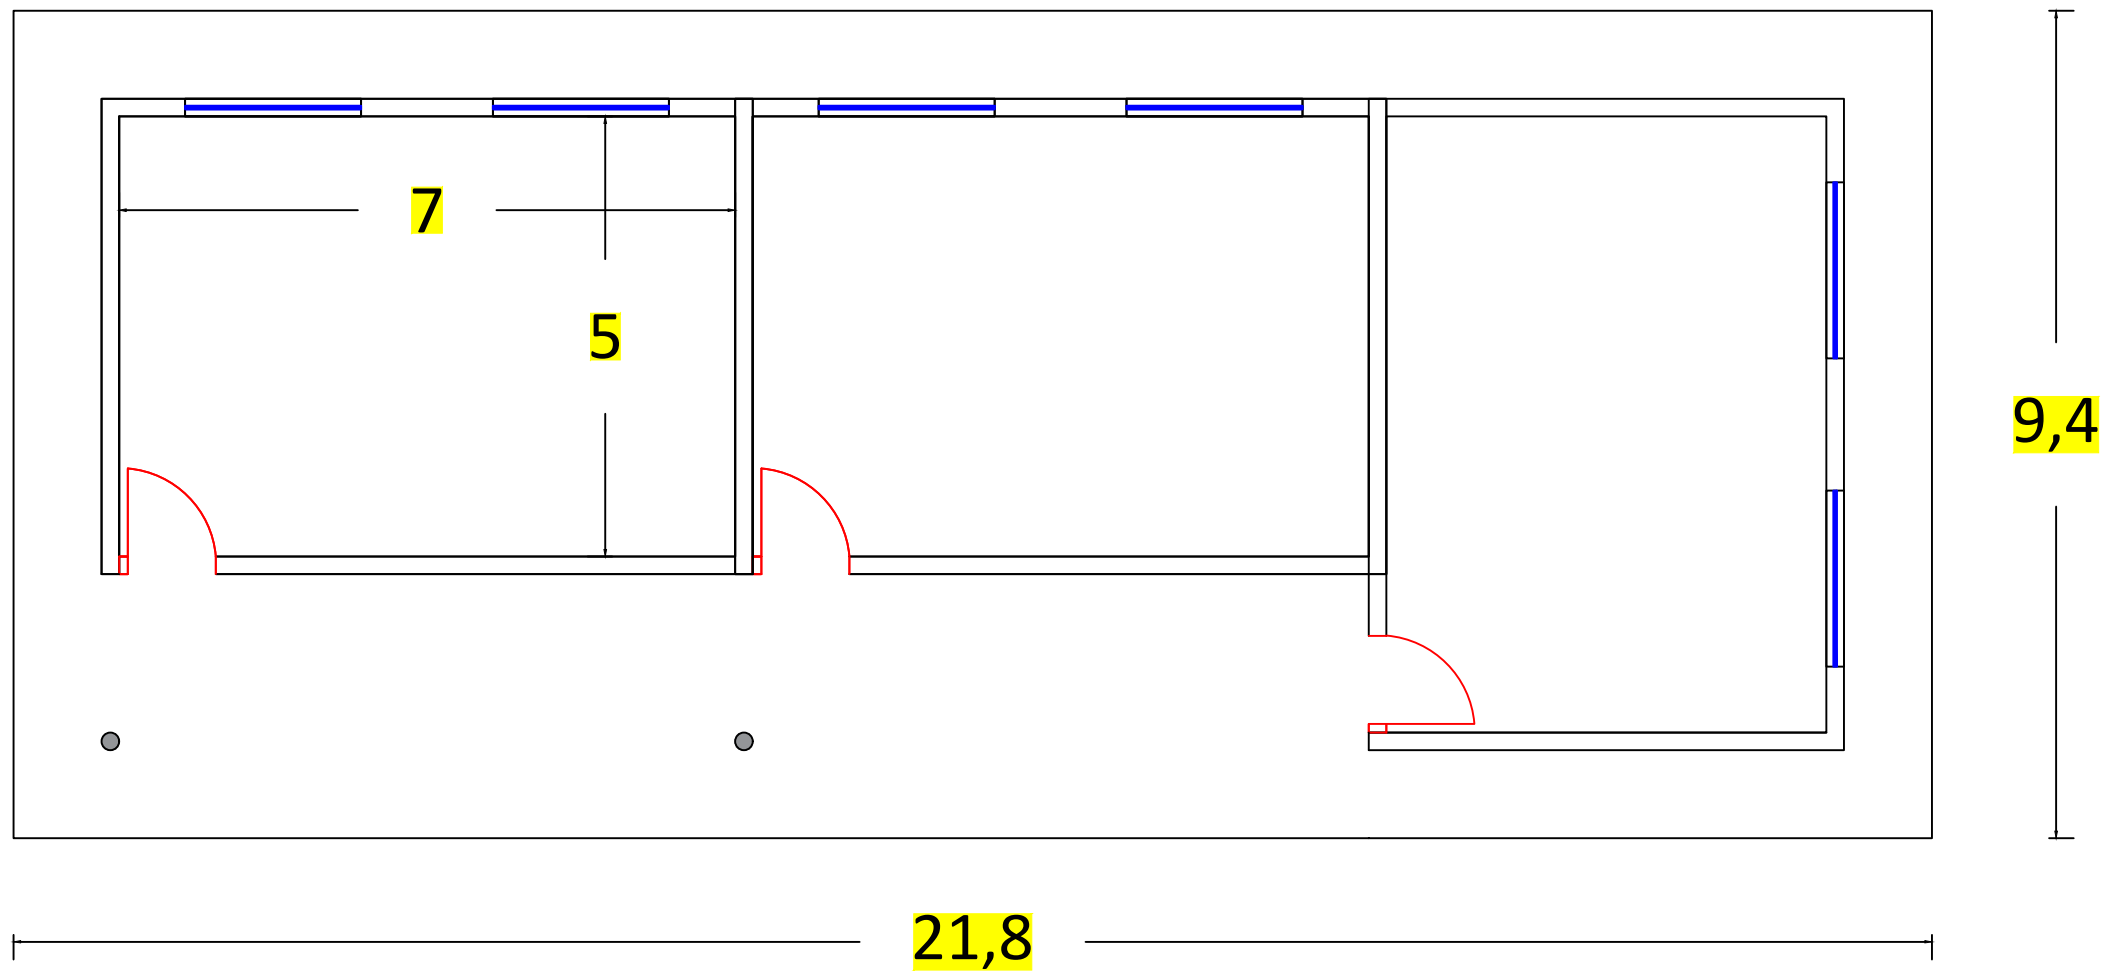

**Sheet Title**

General Plan

**Sheet No.**

1

**Designed By**

UNHCR Technical Unit


**Project Name**

Construction of Three  
Class Rooms at Resa  
Primary School in Bahrka

**Project Place**

Erbil Governorate

**Legend**

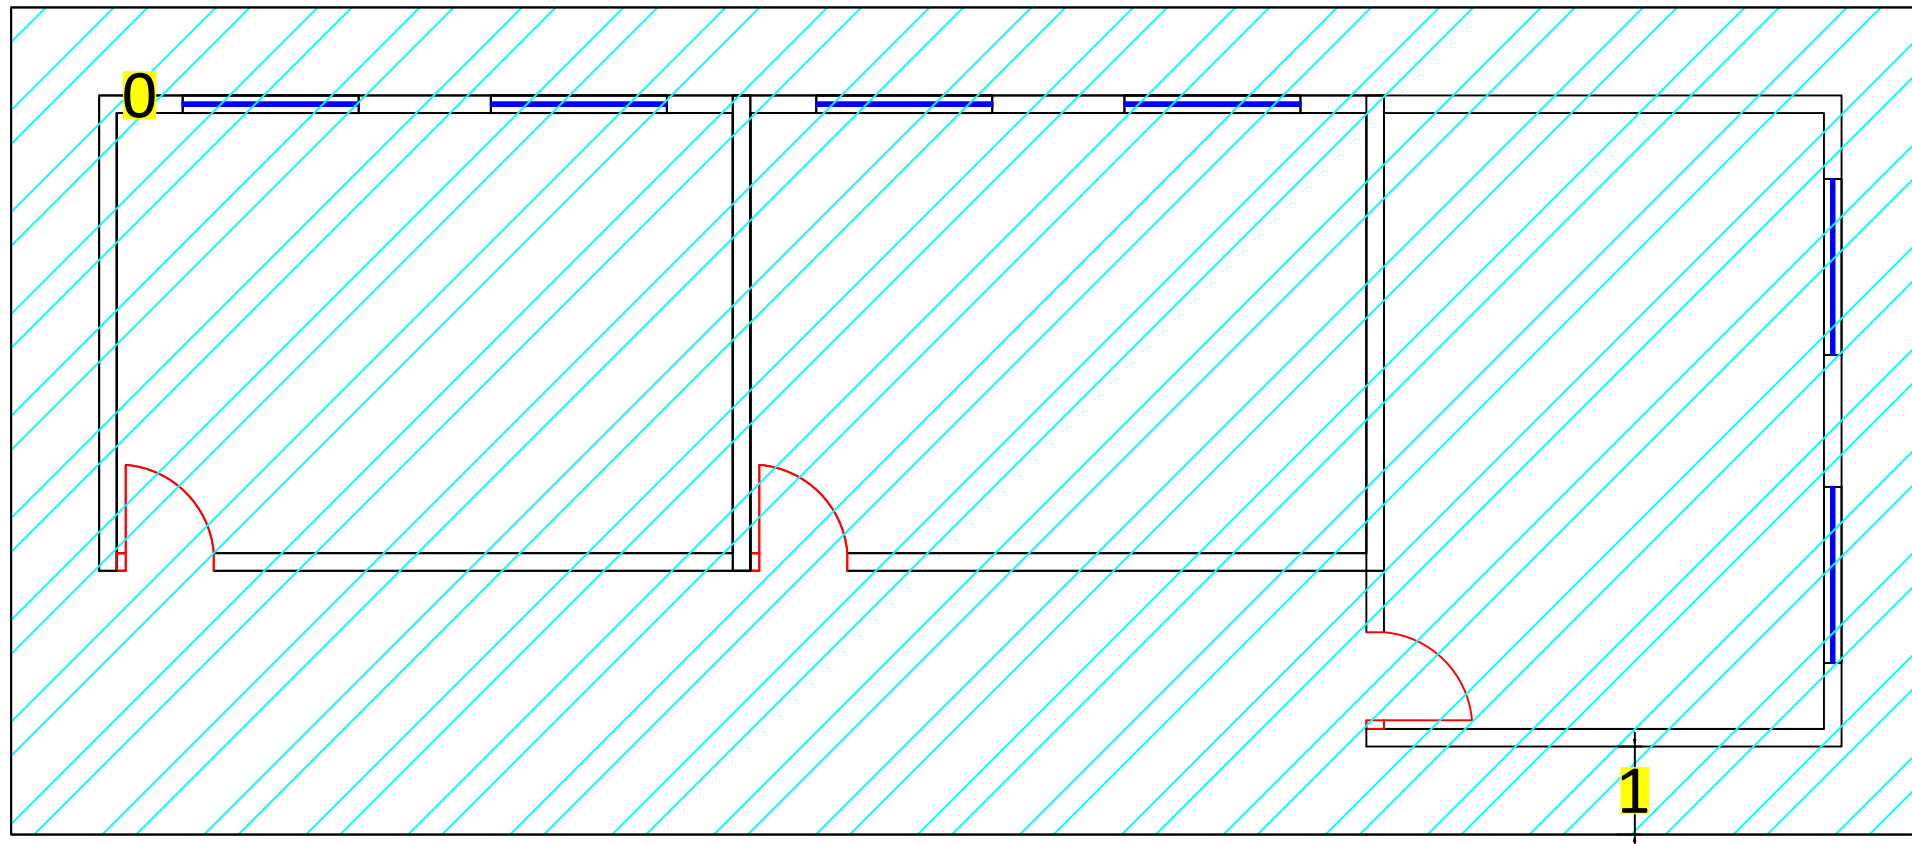

**Sheet Title**

Raft Foundation Plan

**Sheet No.**

2

**Designed By**

UNHCR Technical Unit

**Project Name**

Construction of Three Class Rooms at Resa Primary School in Bahrka

**Project Place**

Erbil Governorate

**Legend**

**Sheet Title**




-Wall Section  
-Raft Foundation Reinforcement  
-Slab Reinforcement  
-Beams Detail

**Sheet No.**

3


**Designed By**

UNHCR Technical Unit

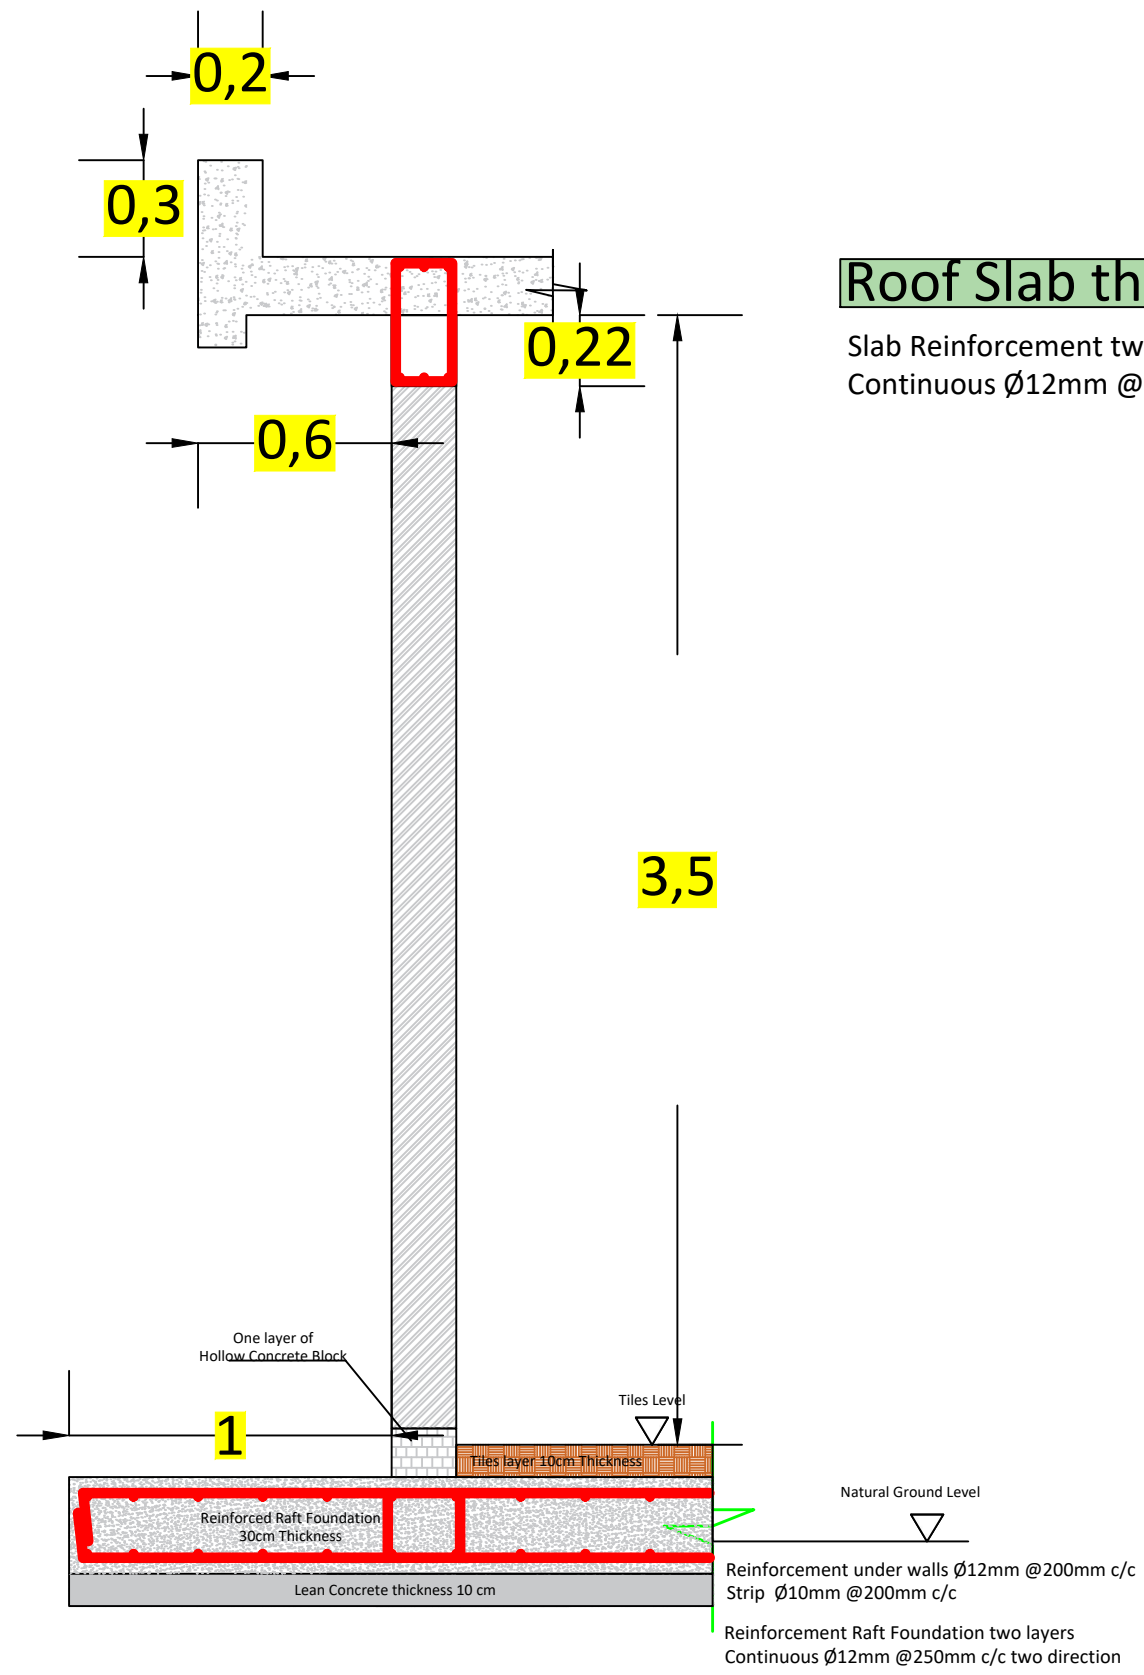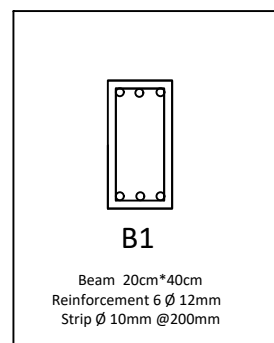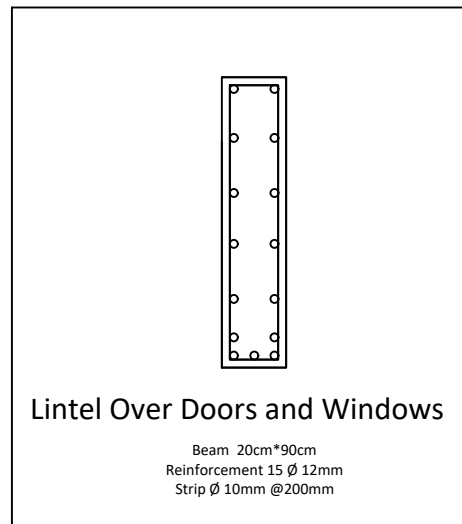

**Roof Slab thickness 18cm**

Slab Reinforcement two layers  
Continuous Ø12mm @150mm c/c two direction

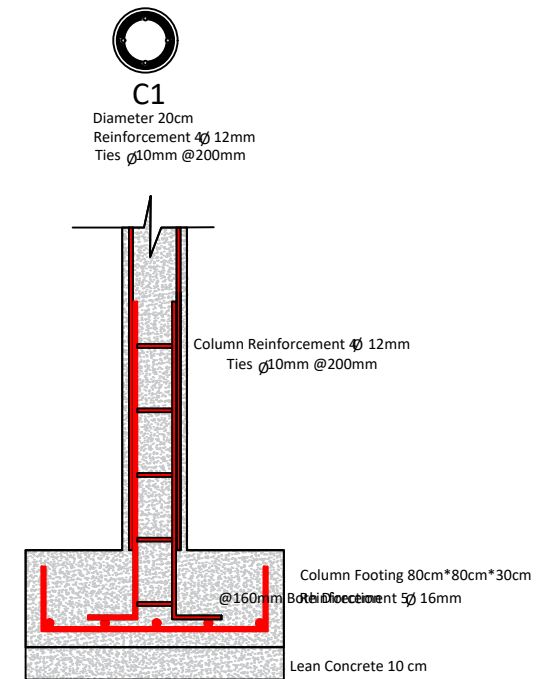

Reinforcement Raft Foundation two layers  
Continuous Ø12mm @250mm c/c two direction

**Project Name**

Construction of Three Class Rooms at Resa Primary School in Bahrka

**Project Place**

Erbil Governorate

**Legend**

**Sheet Title**

Finishing Details


**Sheet No.**

4

**Designed By**

UNHCR Technical Unit

0,58

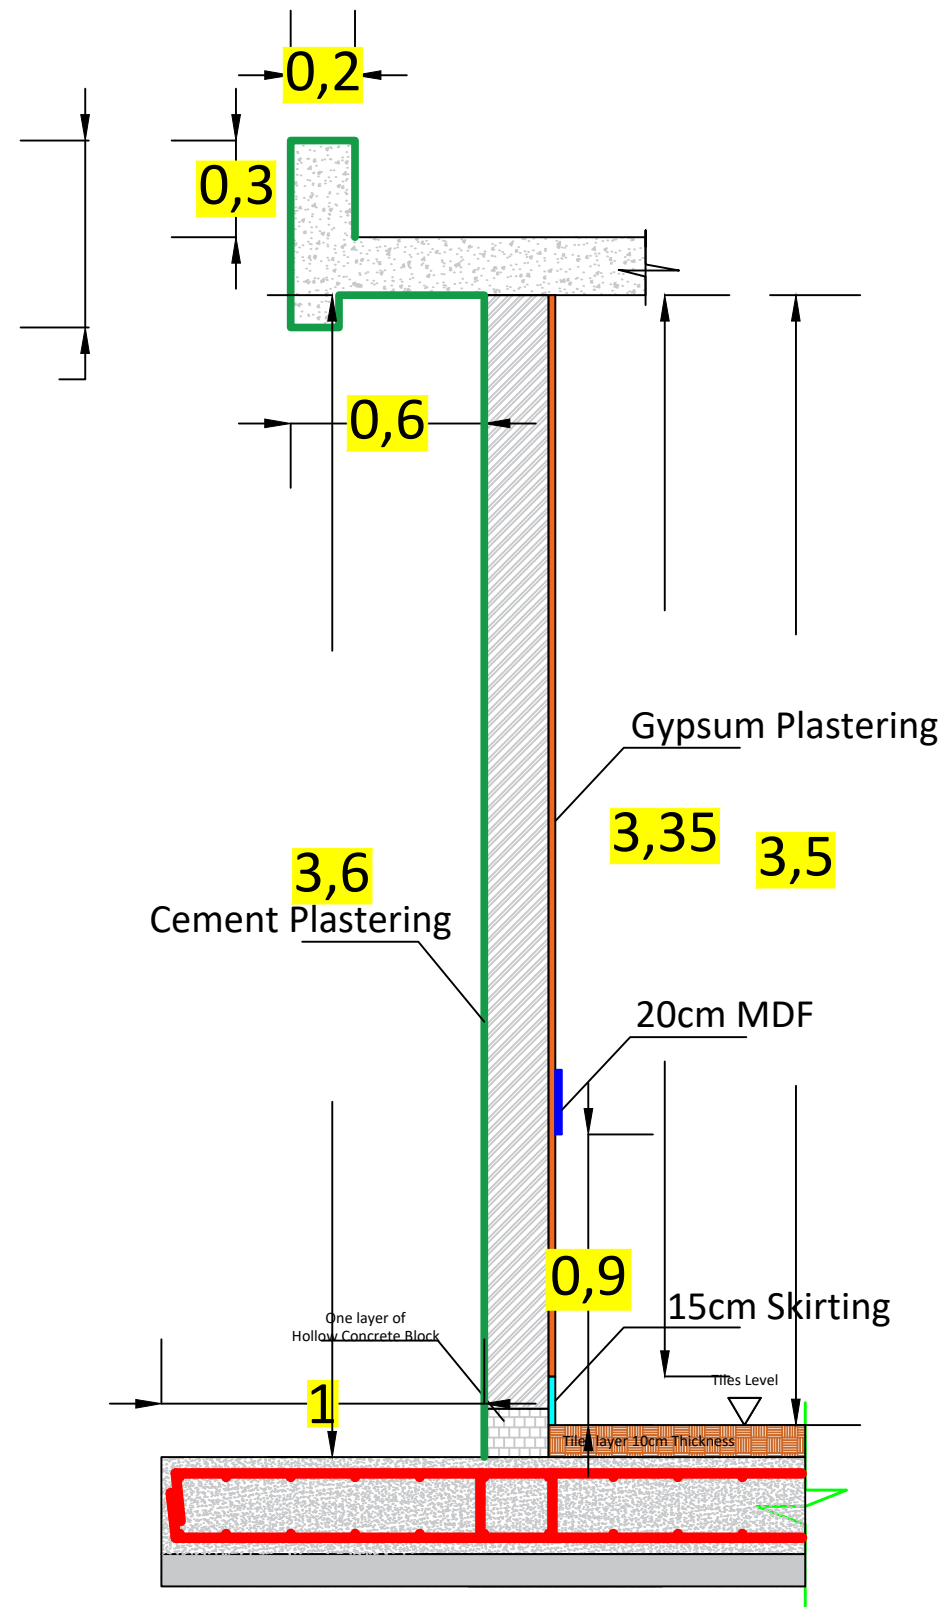


**Project Name**

Construction of Three  
Class Rooms at Resa  
Primary School in Bahrka

**Project Place**

Erbil Governorate

**Legend**

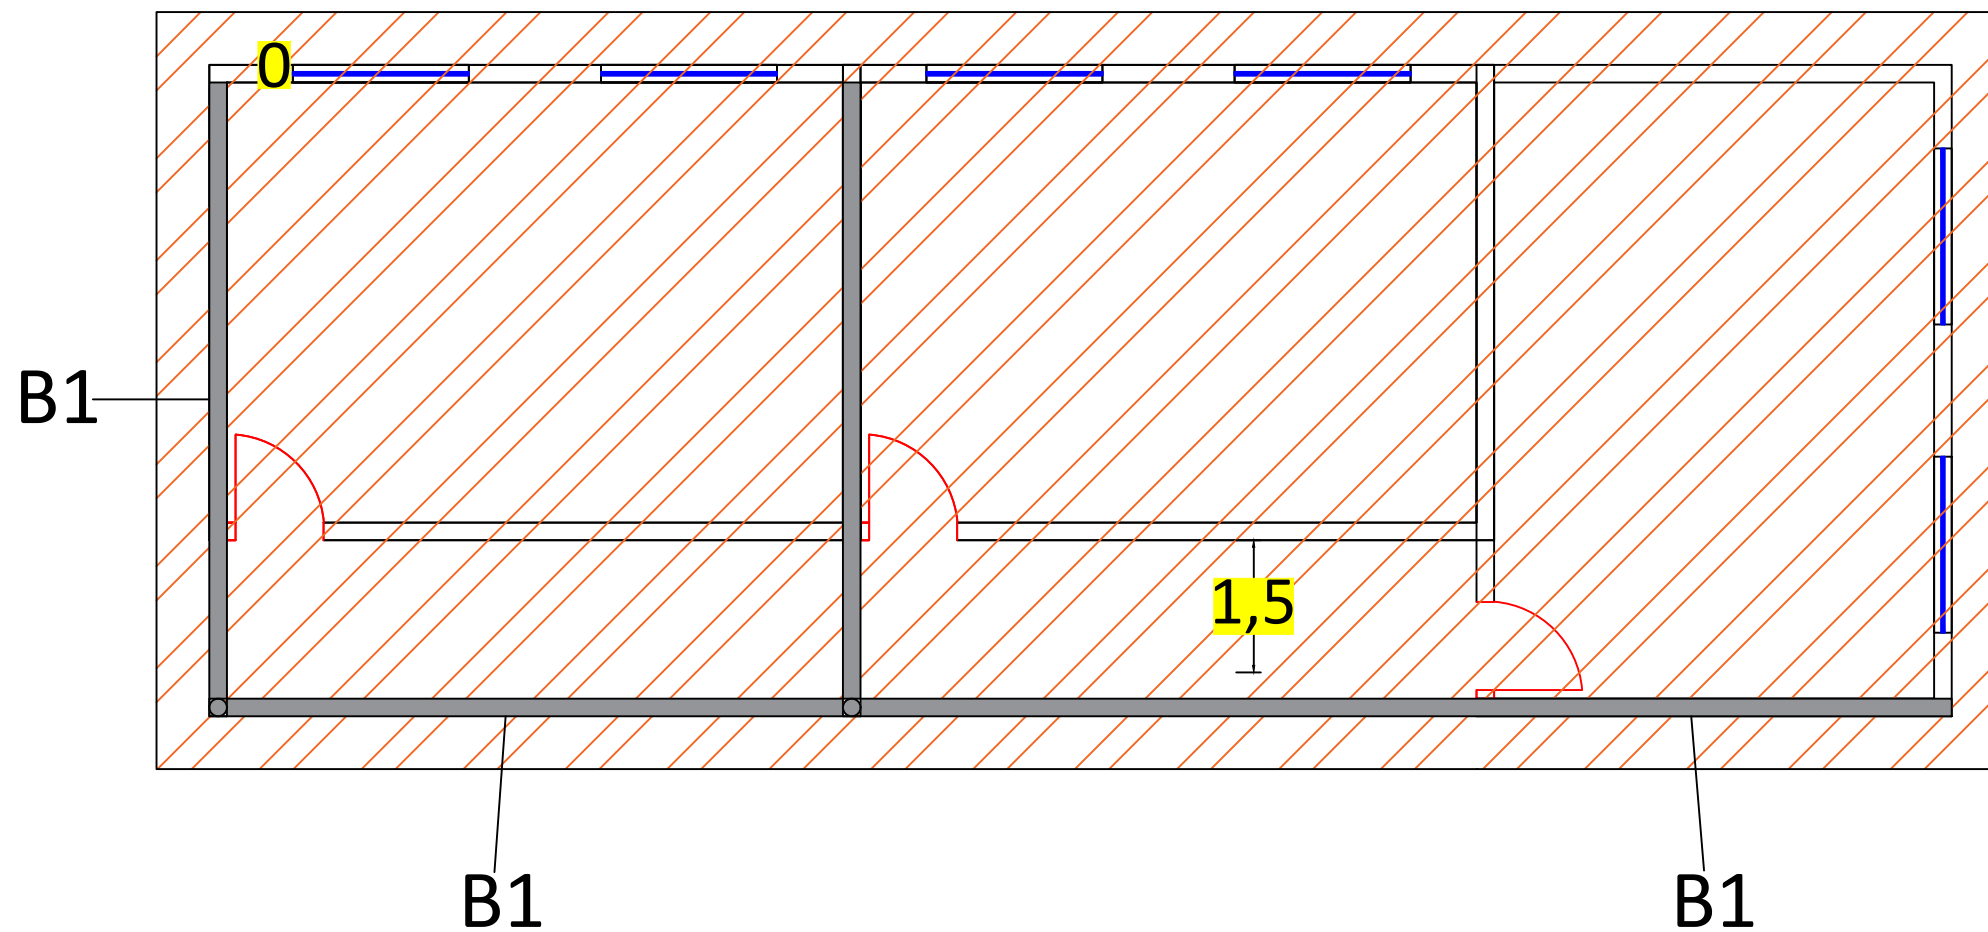

**Sheet Title**

Slab and Beams Plan

**Sheet No.**

5

**Designed By**

UNHCR Technical Unit


**Project Name**

Construction of Three  
Class Rooms at Resa  
Primary School in Bahrka

**Project Place**

Erbil Governorate

**Legend**

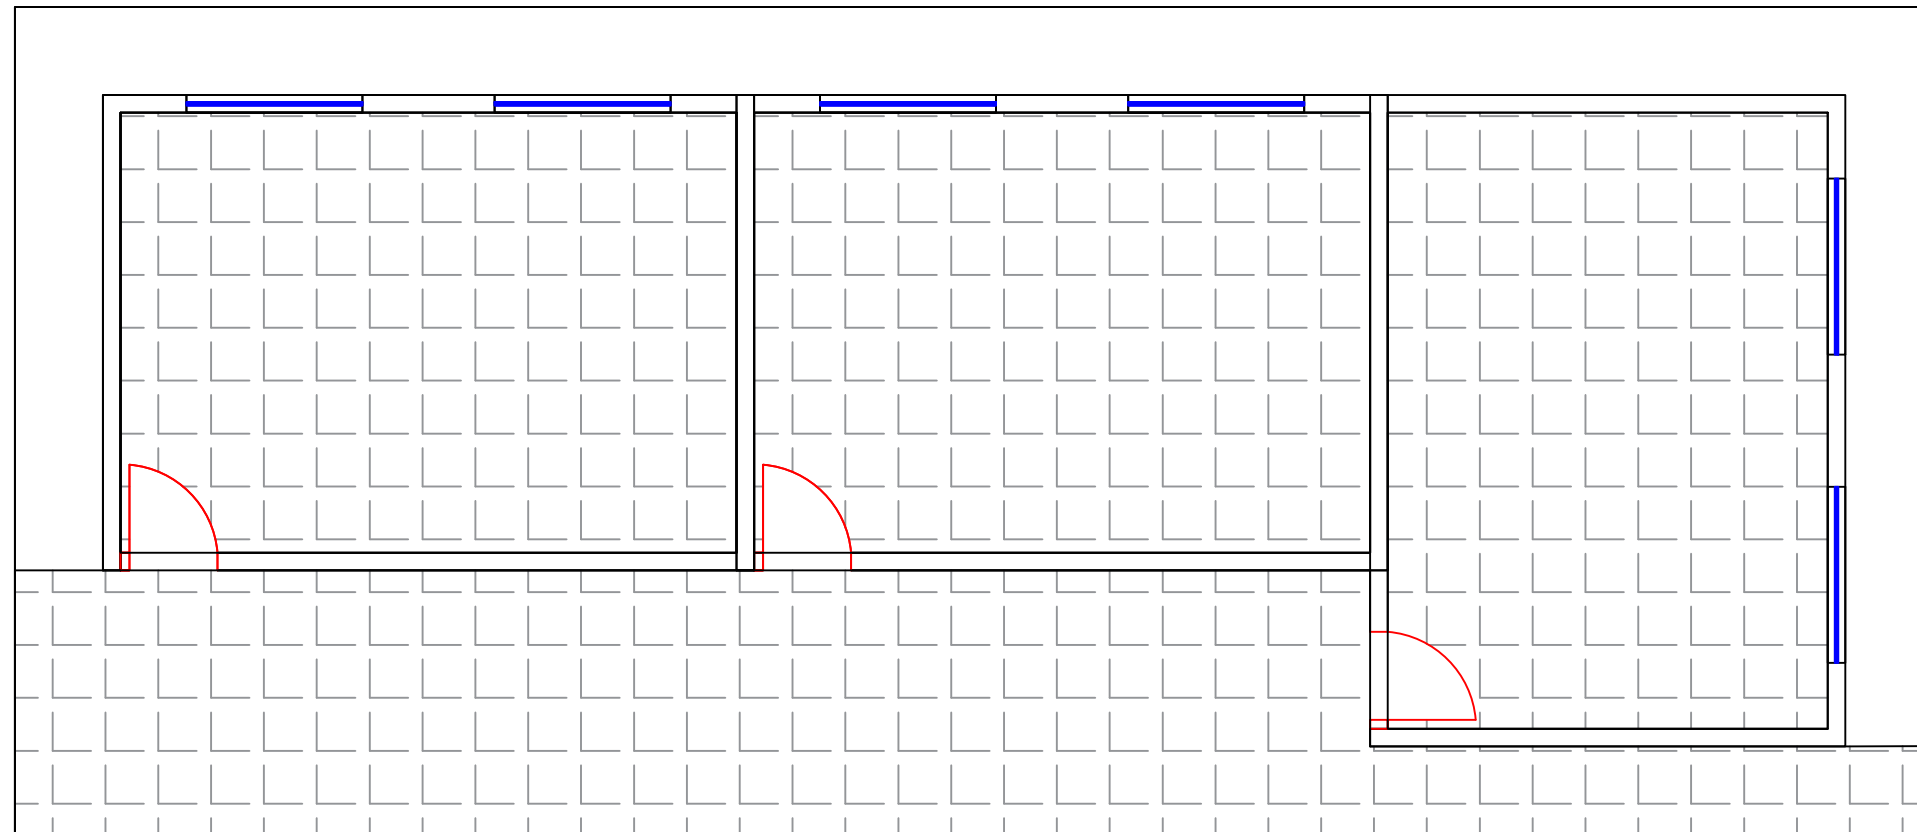

**Sheet Title**

Porcelain Plan

**Sheet No.**

6

**Designed By**

UNHCR Technical Unit


**Project Name**




Construction of Three Class Rooms at Resa Primary School in Bahrka

**Project Place**

Erbil Governorate

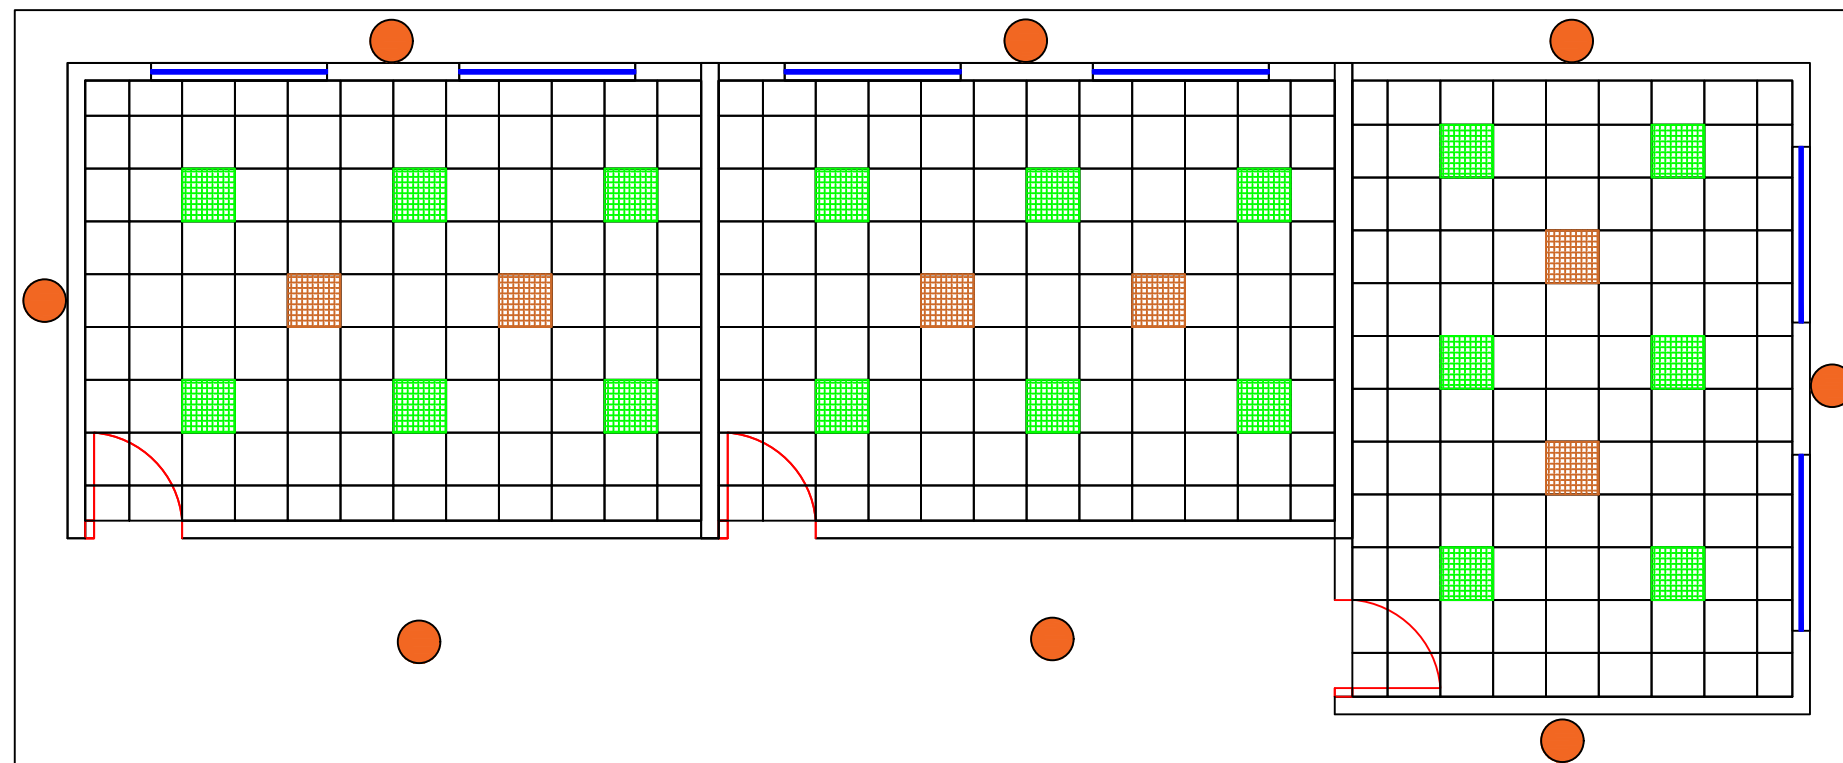**Legend**



-  60x60 Lights
-  Ceiling Fan
-  18 watt (Outdoor LED) light

**Sheet Title**

- Gypsum False Ceiling  
- Electrical Details

**Sheet No.**

7

**Designed By**

UNHCR Technical Unit

**Project Name**

Construction of Three  
Class Rooms at Resa  
Primary School in Bahrka

**Project Place**

Erbil Governorate

**Legend**

**Sheet Title**


Doors and Windows Details

**Sheet No.**


8

**Designed By**

UNHCR Technical Unit

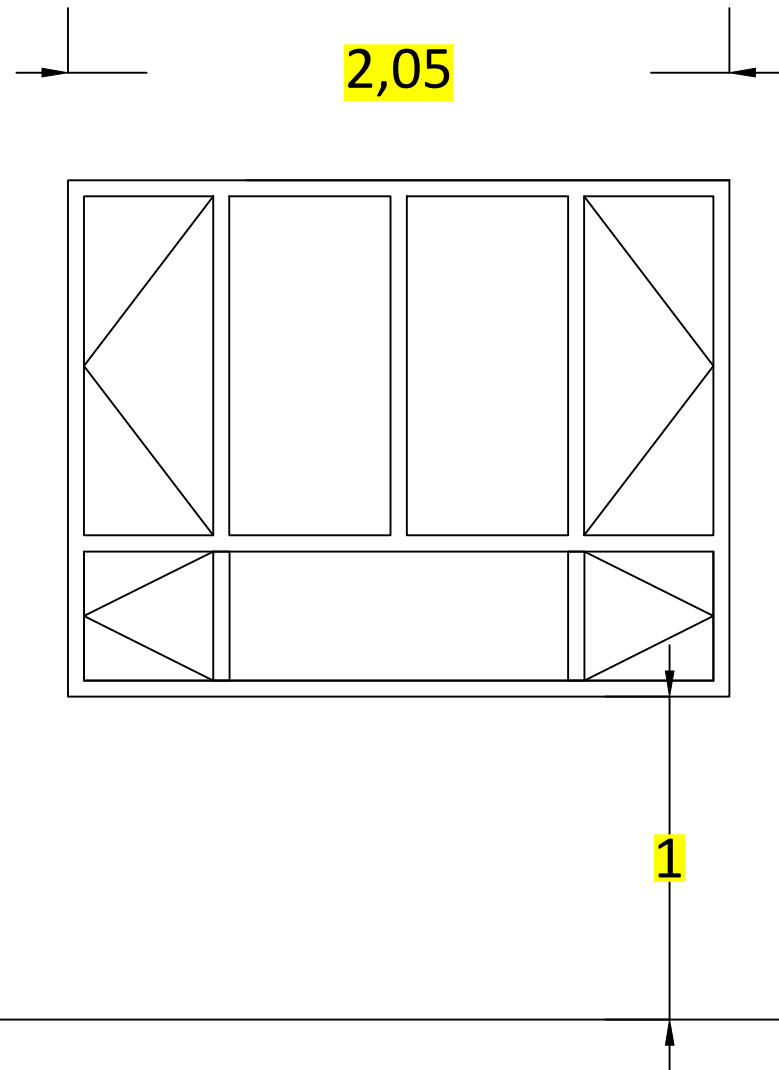

**Aluminum  
Window**

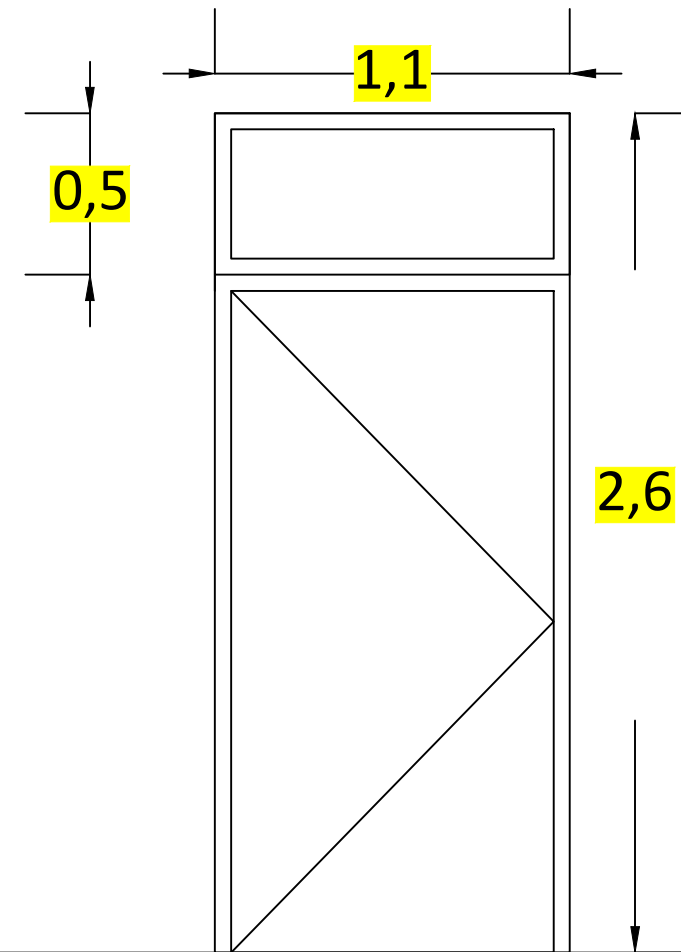

**Classroom Door**